


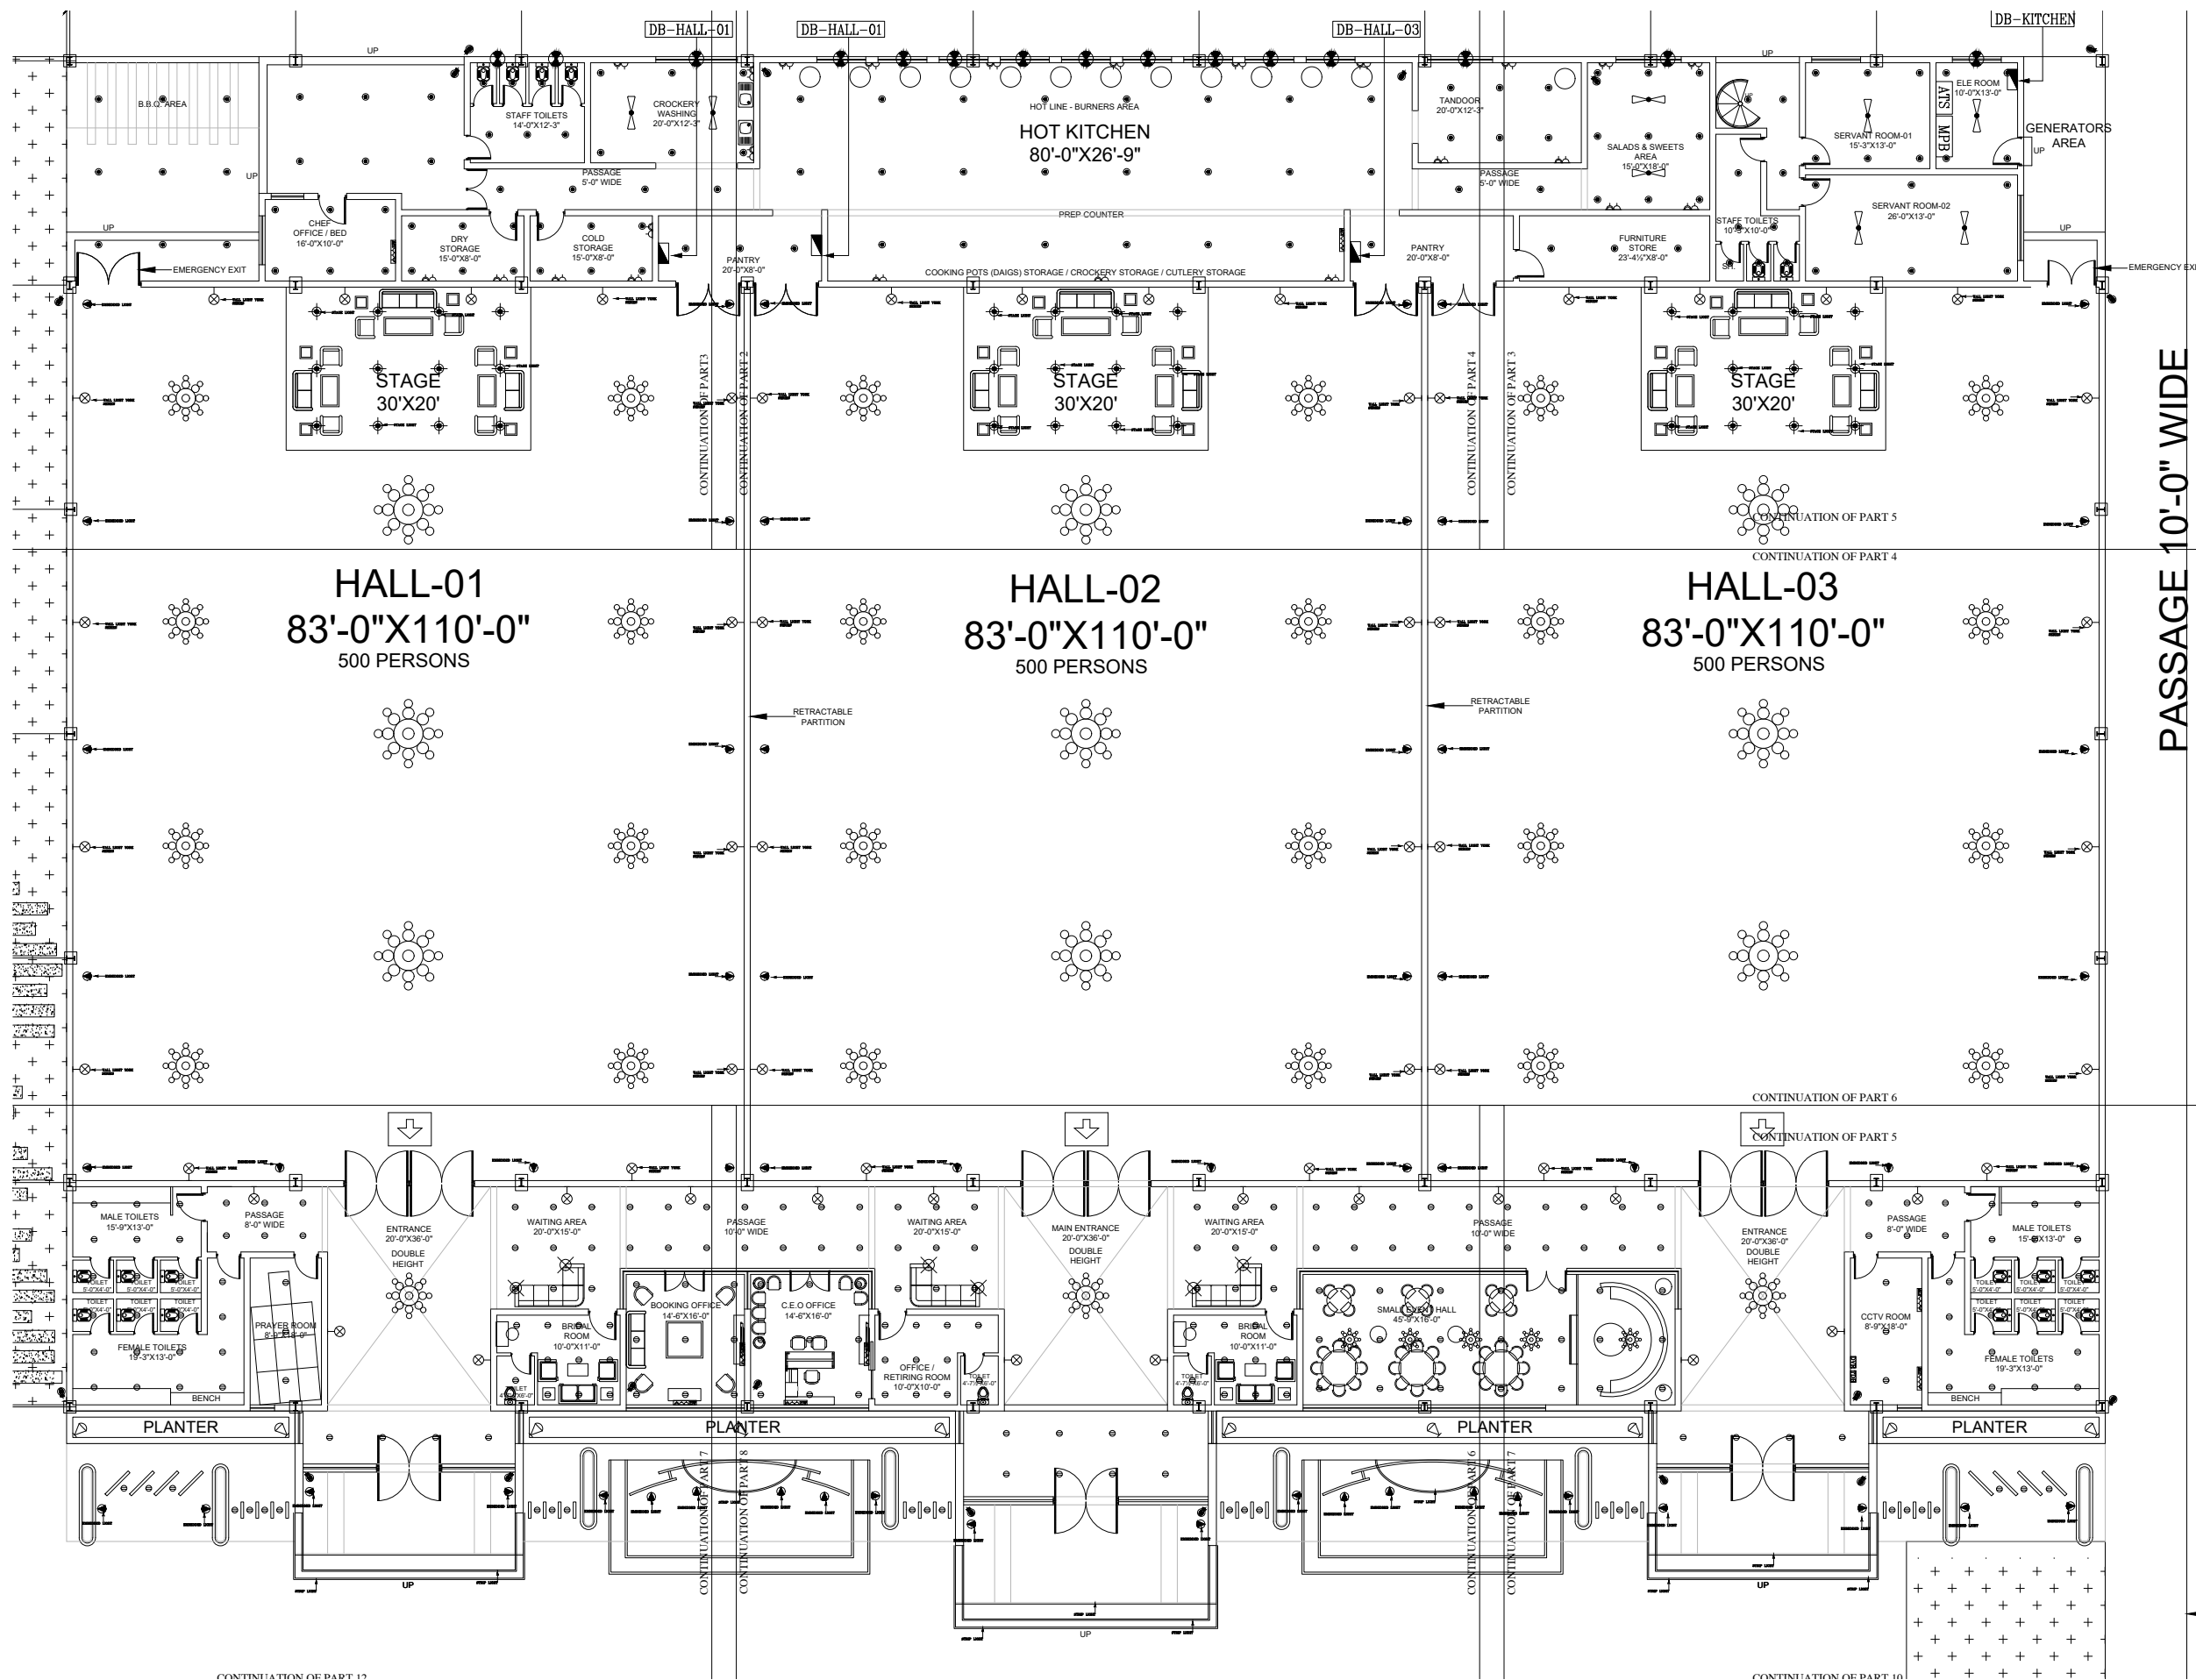

PASSAGE 10'-0" WIDE



ARCHITECT.

KASWA DESIGN SERVICES
Consulting Architect & Interior Designers
379 TARIQ BLOCK, NEW GARDEN TOWN, LAHORE
042-35858456, 0336-5858450, kaswadesign@gmail.com



ELECTRICAL CONSULTANT



Elektro Serve
ENGINEERING, EVALUATION & CONTRACT
MANAGEMENT CONSULTANT
HOUSE NO 289-D, REHMAN ABAD
JOHER TOWN LAHORE
PHONE: 042-35194210, 0321-8484040
info@elektroserve.com

DESIGNED BY:
ELEKTRO SERVE

CHECKED BY:
Engr:Usman

APPROVED BY:
ASAD MALIK

DRAWN BY:
M.JABBAR

DATE:
MAY 2026

SCALE:
N. T. S

JOB NO:
27/26

DRAWING NO:
E-04

COMP. FILE NO:
D:/M.JABBAR/ELEKTRO SERVE

TITLE

ELECTRICAL LEGEND

PROJECT

EVENT COMPLEX, QADIRABAD
MR.GUL NAWAZ KHAN