


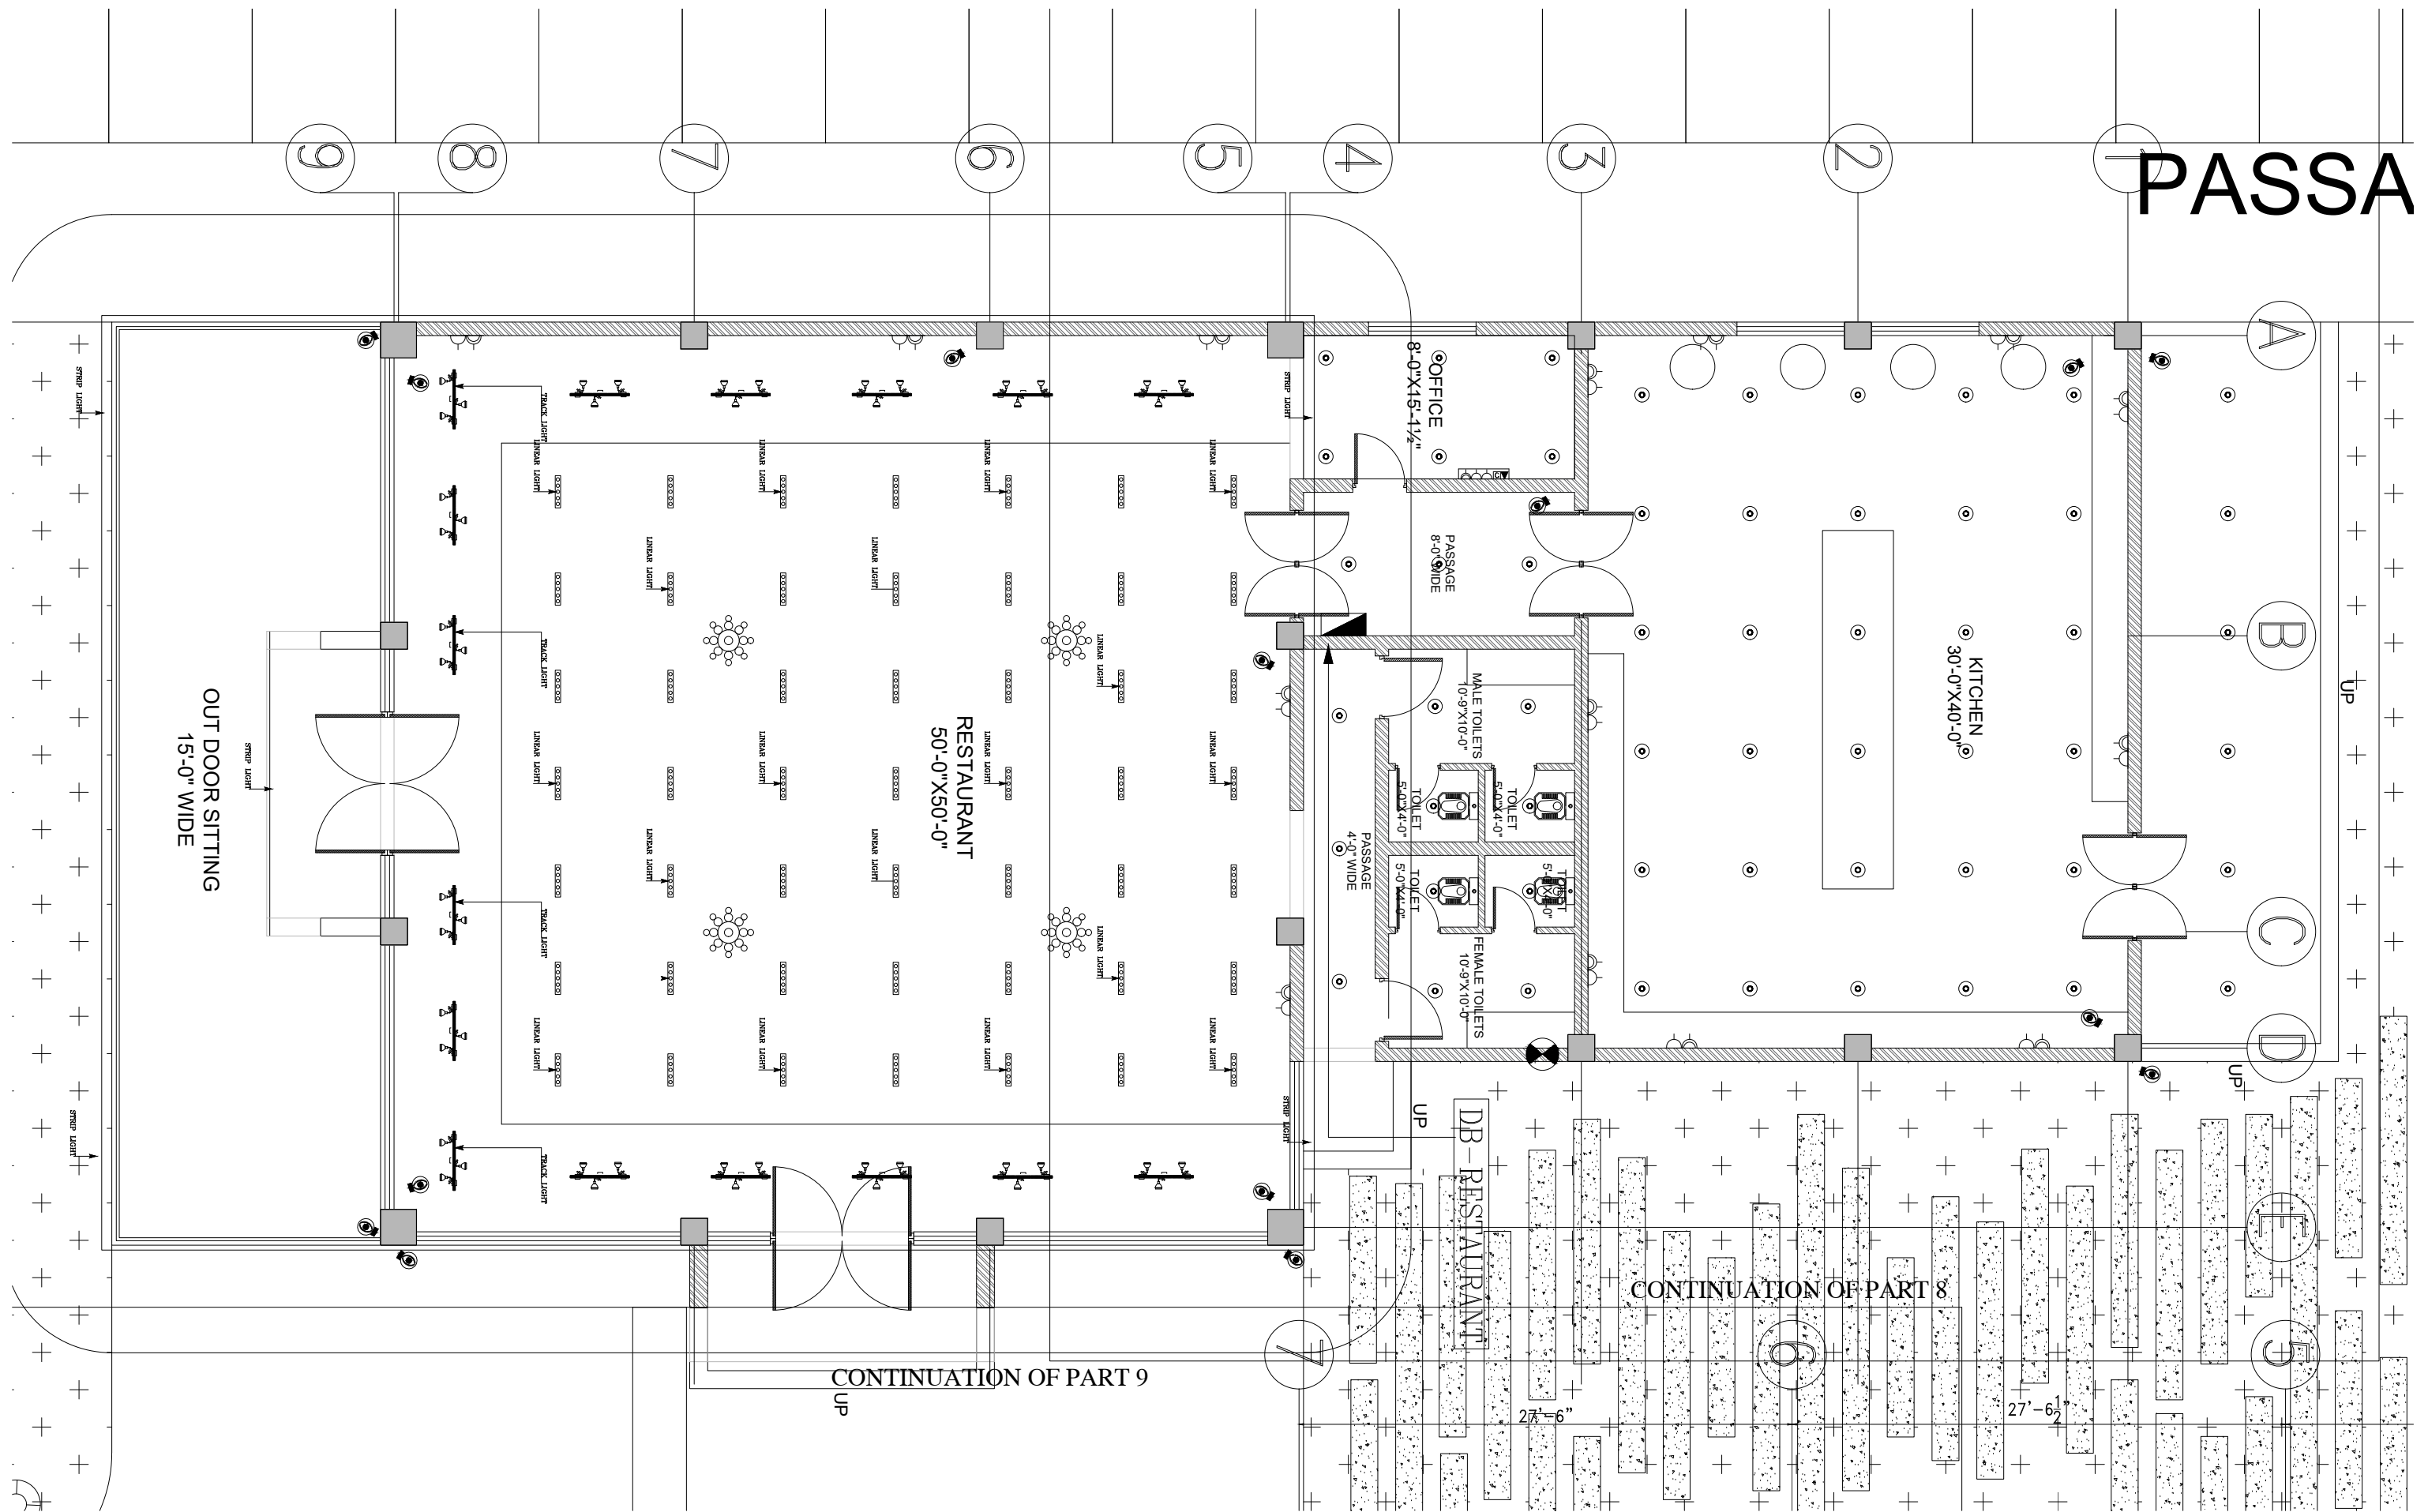

PASSA

CONTINUATION OF PART 9

CONTINUATION OF PART 8

ARCHITECT.
KASWA DESIGN SERVICES
Consulting Architect & Interior Designers
379 TARIQ BLOCK, NEW GARDEN TOWN, LAHORE
042-35858456, 0336-5858450, kaswadesign@gmail.com

ELECTRICAL CONSULTANT
Elektro Serve
ENGINEERING, EVALUATION & CONTRACT
MANAGEMENT CONSULTANT
HOUSE NO 289-D, REHMAN ABAD
JOHER TOWN LAHORE
PHONE: 042-35194210, 0321-8484040
info@elektroserve.com

DESIGNED BY:
ELEKTRO SERVE
CHECKED BY:
Engr:Usman
APPROVED BY:
ASAD MALIK

DRAWN BY:
M.JABBAR
DATE:
MAY 2026
SCALE:
N. T. S

JOB NO:
27/26
DRAWING NO:
E-05
COMP. FILE NO:
D:/M.JABBAR/ELEKTRO SERVE

TITLE
ELECTRICAL LEGEND

PROJECT
EVENT COMPLEX, QADIRABAD
MR.GUL NAWAZ KHAN